


A B C D E F G H

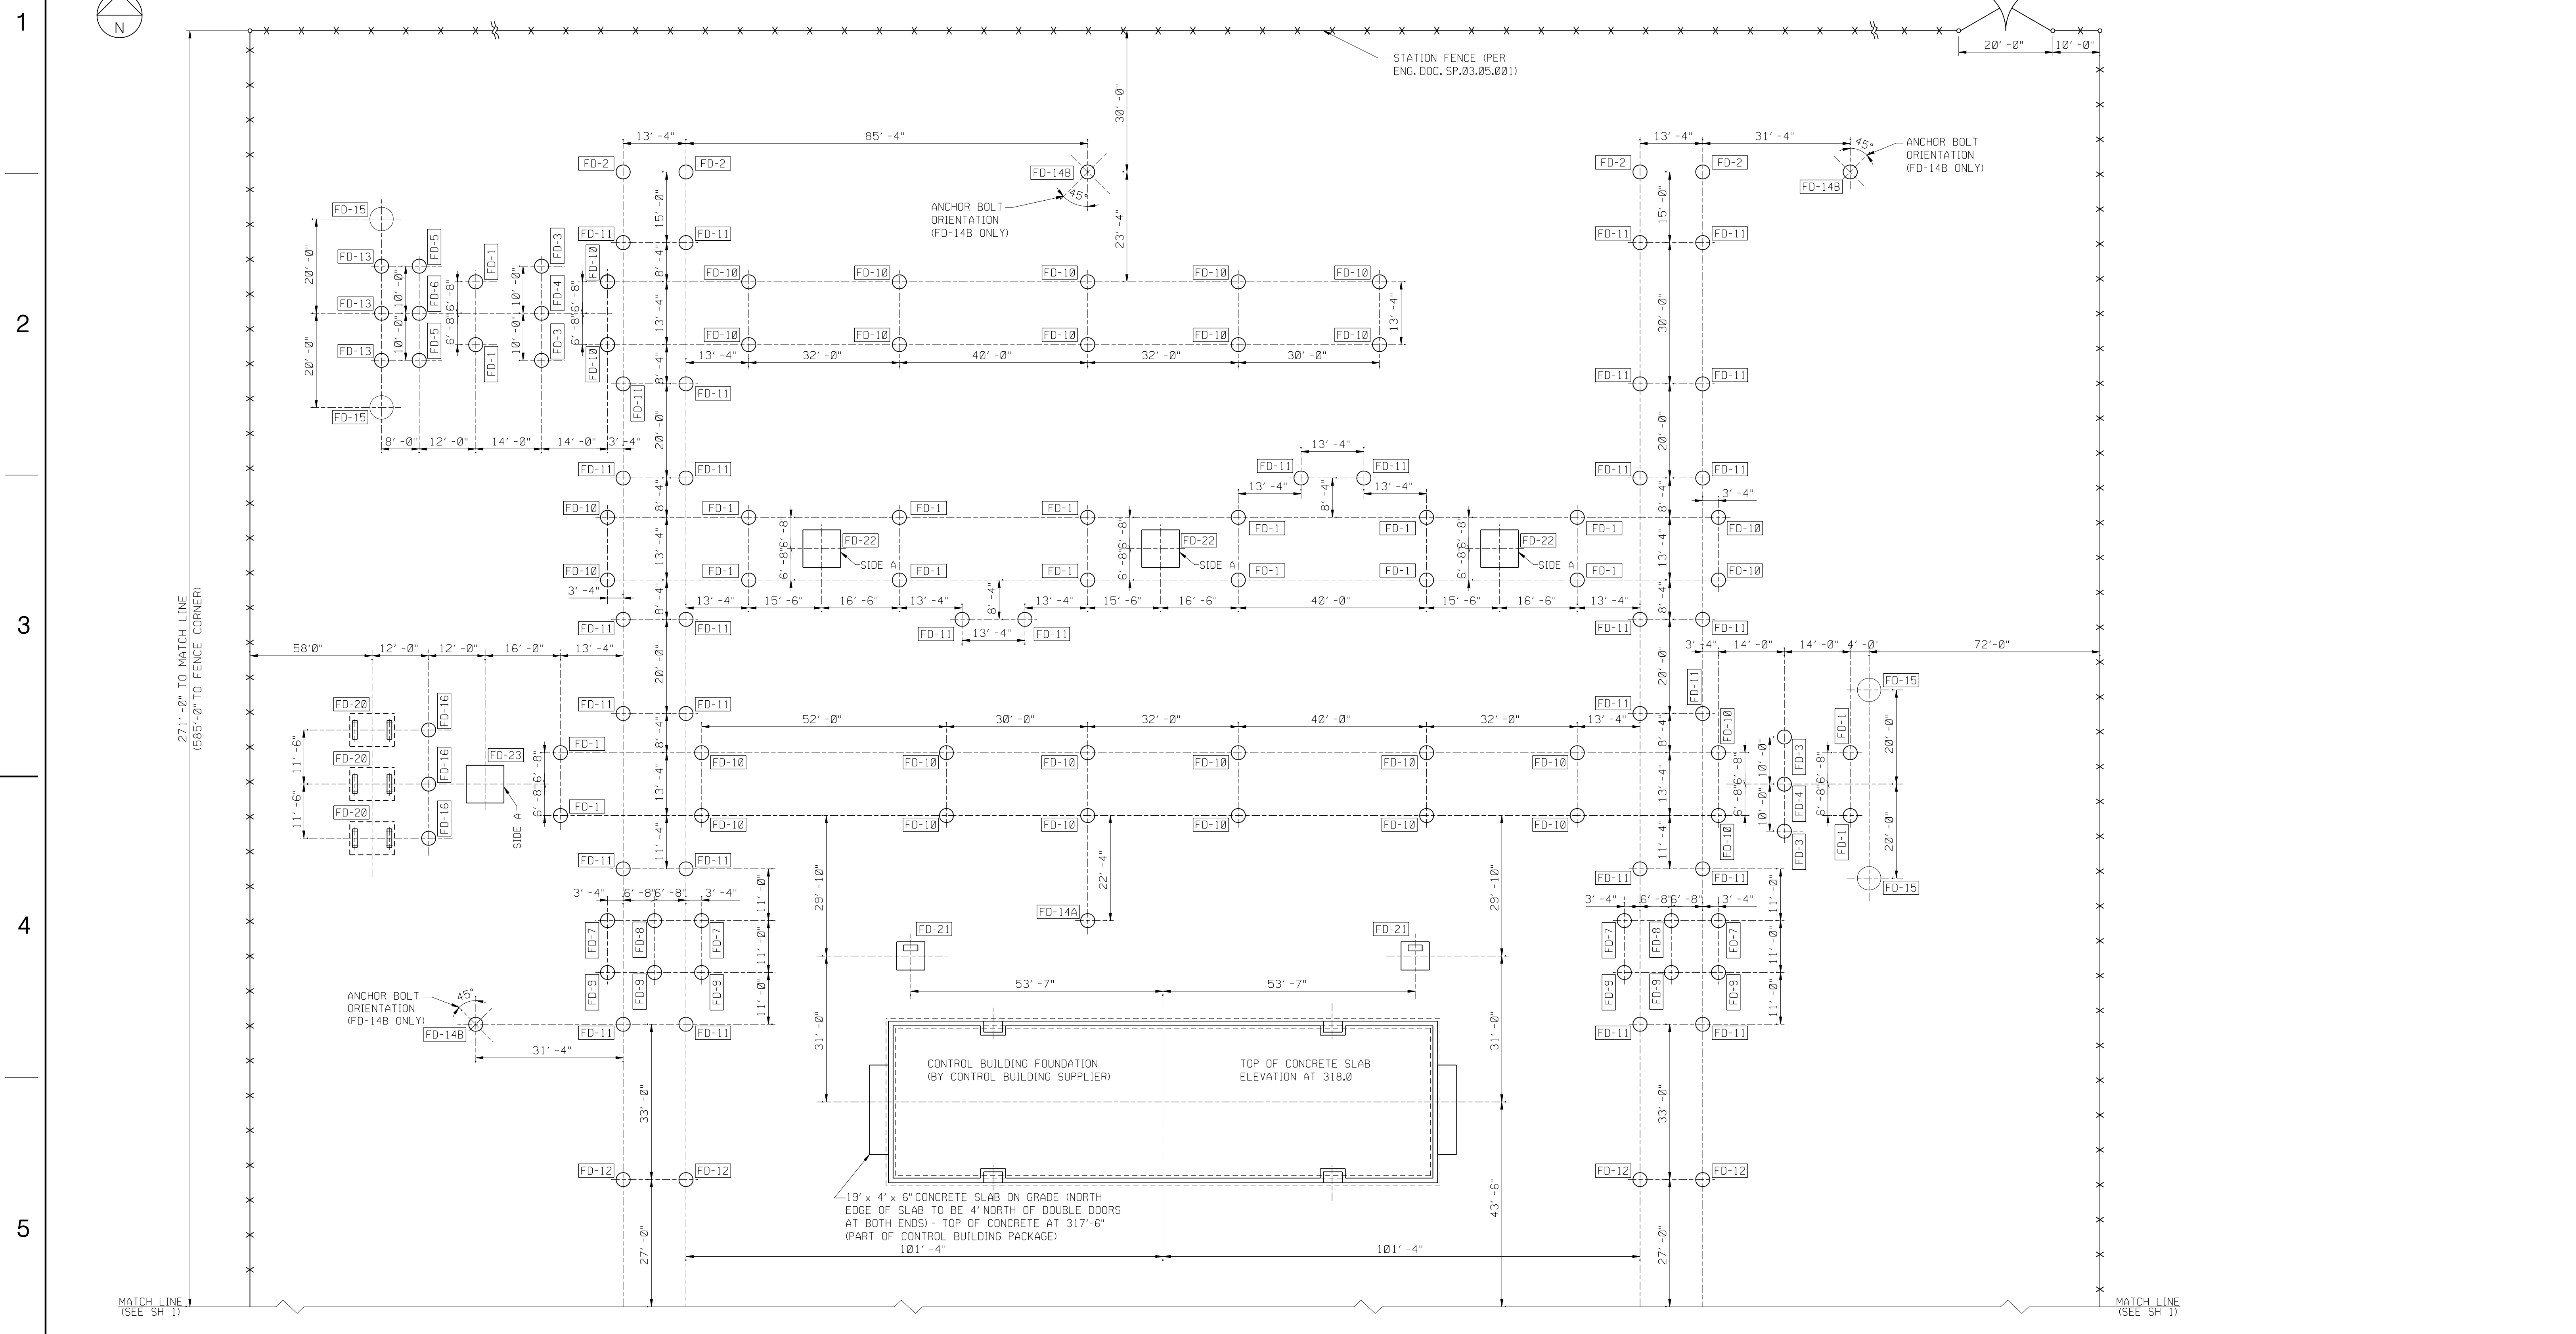

FOUNDATION PLAN B  
SCALE: 1/16" = 1'-0"

TOP OF CONCRETE ELEVATION FOR ALL FOUNDATIONS AT 317'-6" (EXCEPT CONTROL BUILDING)

CONFIDENTIALITY STATEMENT  
 This document contains confidential and proprietary information of the National Grid Company, Inc. (National Grid). It is to be used only by authorized personnel for National Grid solely in connection with the specific project for which it has been transmitted. Any other use, its transmission to third parties, or its reproduction without prior express written authorization of National Grid is strictly prohibited.

|  |  |          |     |     |     |     |
|--|--|----------|-----|-----|-----|-----|
| 210 GREENFIELD RD., STE 102<br>LIVERPOOL, NY 13088 |  |          |     |     |     |     |
| CONTRACT NO.                                       | 103014-E0011-36051020                                    |          |     |     |     |     |
| FILE NO.   | 36051020-020   |          |     |     |     |     |
| REV  | REV DESCRIPTION  | DATE     | DES | CHK | APP | P/E |
| A  | ISSUE FOR BID & CLIENT REVIEW                            | 05/27/09 | EC  | EC  | ROW |     |
| B  | INCORPORATED UTILITY COMMENTS AND ISSUE FOR CONSTRUCTION | 06/26/09 | EC  | EC  | ROW |     |

|  |  |--|--|-------------------------------------|--|-----|--|------|--|----------------------------------|--|-----|--|-----|--|--|--|-------------------------------|--|--|--|---|--|-----|--|-----|--|------|--|----------|--|----------------|--|--------------------------|--|---------------------|--|
| CONDUIT PLAN<br>STEEL ERECTION PLAN<br>ELECTRICAL PLAN |  | D-36068-E<br>D-36100-E<br>D-36114-E |  |     |  |      |  |                                  |  |     |  |     |  | DES. APPROVED<br>DR. APPROVED<br>CK. APPROVED<br>APP. APPROVED |  | PREPARED BY<br>ACCOUNT NUMBER |  | LUTHER FOREST SUBSTATION<br>115KV STATION<br>FOUNDATION PLAN B |  | ORIGINAL ISSUE DATE<br>FILE INDEX<br>DRAWING NUMBER<br>SHEET NUMBER |  |     |  |     |  |      |  |          |  |                |  |                          |  |                     |  |
| REFERENCE DESCRIPTION                                  |  | DRAWING NUMBER                      |  | NO. |  | DATE |  | DESCRIPTION OF ISSUE OR REVISION |  | DR. |  | CK. |  | APP.   |  | NO.                           |  | DATE   |  | DESCRIPTION OF ISSUE OR REVISION                                    |  | DR. |  | CK. |  | APP. |  | APPROVED |  | ACCOUNT NUMBER |  | LUTHER FOREST SUBSTATION |  | ORIGINAL ISSUE DATE |  |
|  |  7.3-L3-E8      |  | D-36051-E                |  |                     |  |
|  |  2, FINAL       |  |                          |  |                     |  |